



CR/2006/044S/FUL

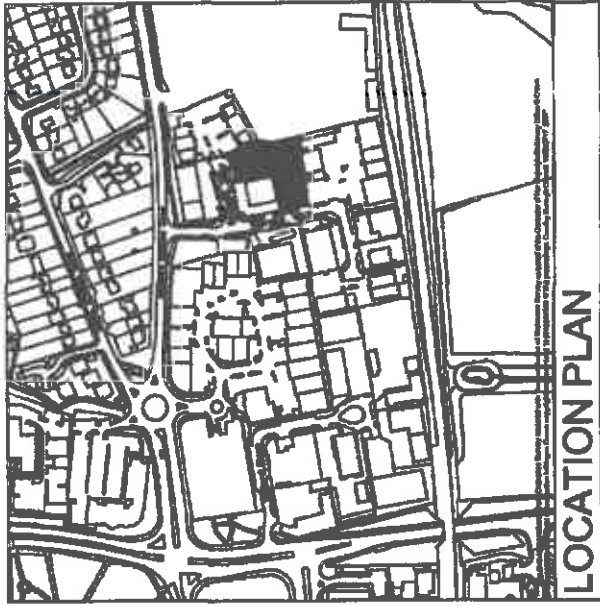

DATE	BY	REVISION
PREPARED BY: [Name] CHECKED BY: [Name] DATE: [Date] PROJECT NO.: [Number] SHEET NO. OF [Total] SHEETS		
NAME OF PROPERTY PROJECT NAME		
ADDRESS AND DISTRICT		
DRAWING TITLE		
CITY AND DISTRICT		
SCALE	DATE	DATE
1:100	2006	2006
DRAWING NO. 01044S		SHEET NO. 01044S/01

FIRE ALARM SYSTEM ZONE ALLOCATION

Otto Back Healthcare Plc  
 Unit 1 & 2, Spindle Court  
 Spindle Way  
 Crawley  
 Sussex  
 RH10 1AX

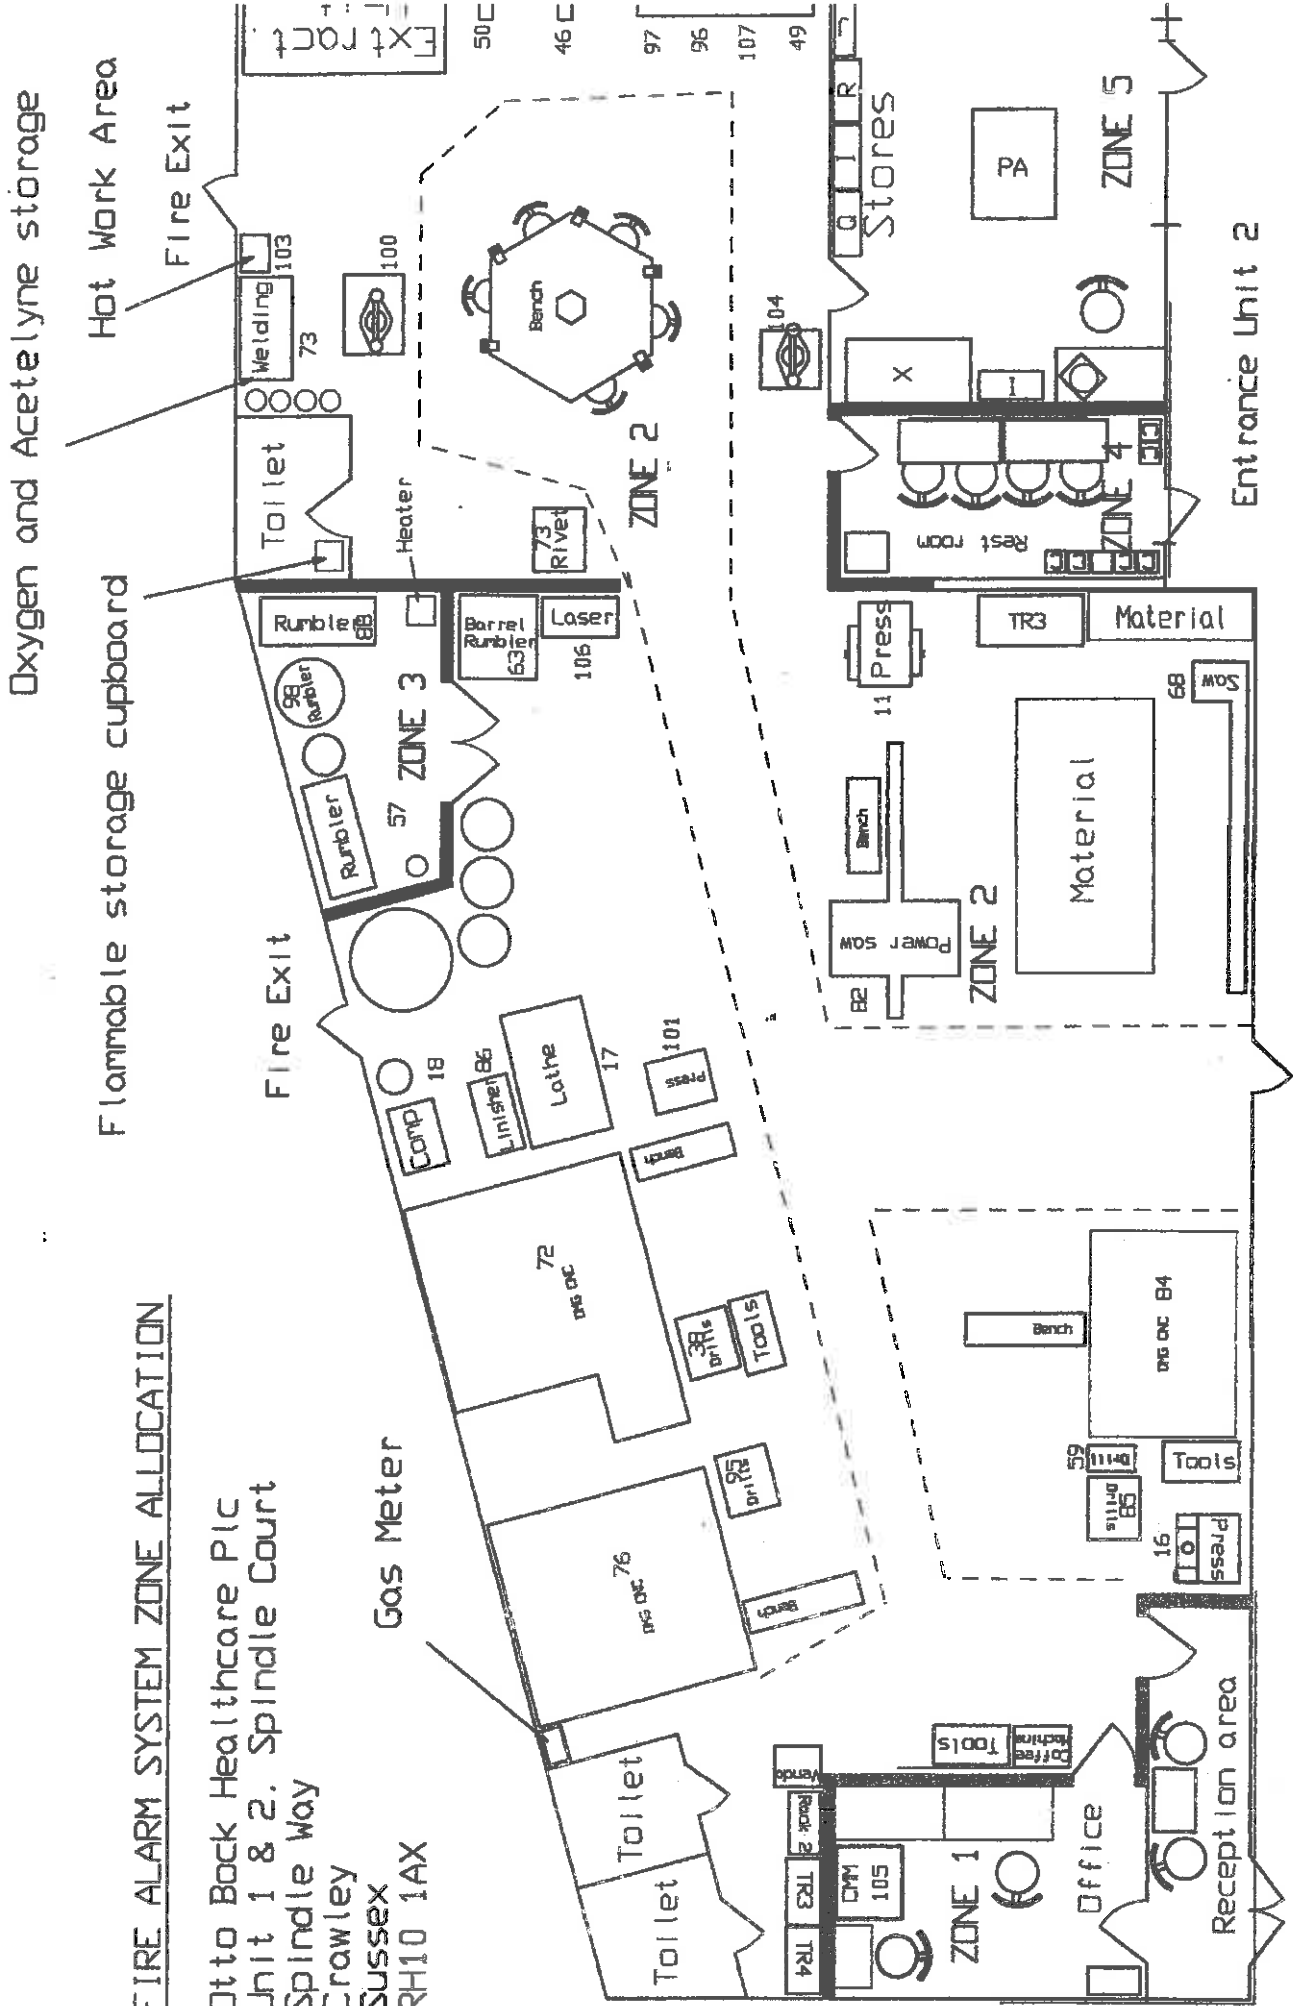

Entrance Unit 1

Entrance Unit 2