


Notes

FIRST FLOOR

AREA 1

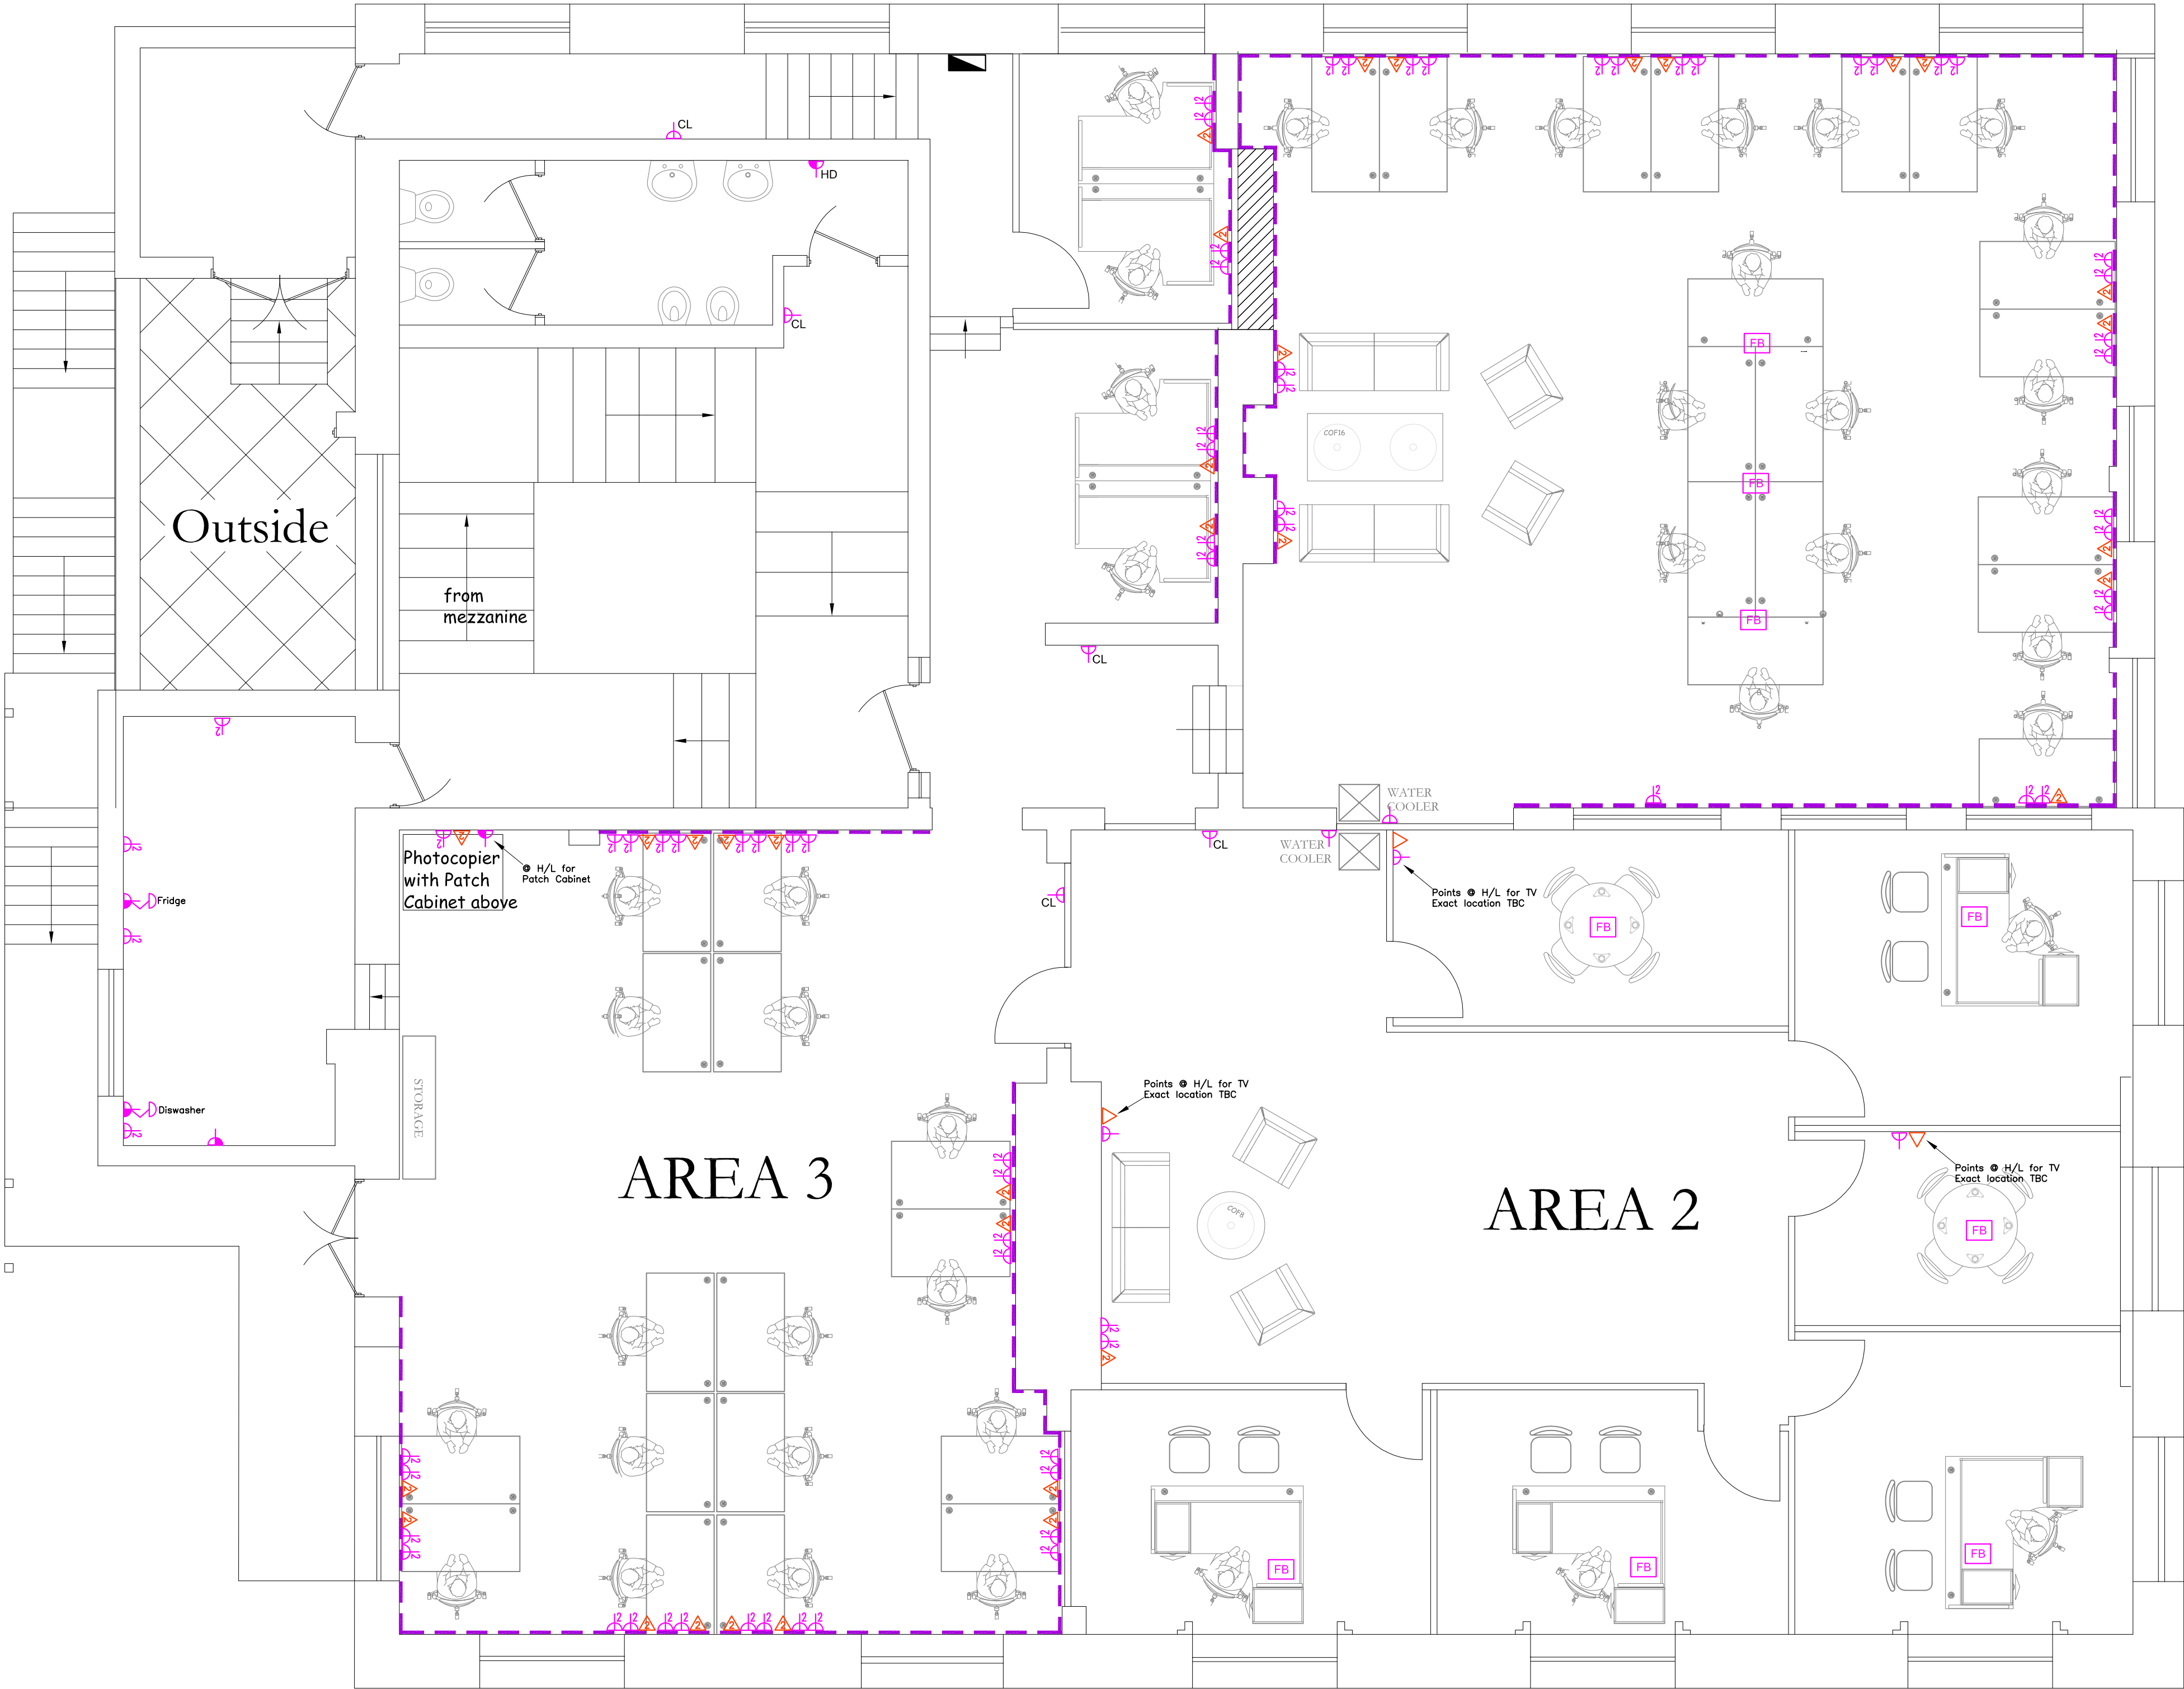

SMALL POWER	
SYMBOL	DESCRIPTION
	Distribution Board
	Single 13A Switched Socket Outlet
	Twin 13A Switched Socket Outlet
	Switched Fused Connection Outlet (SFCO)
	Unswitched Fused Connection Outlet
	SFCO controlling 13A Socket at low level
	Floor Box c/w 2 x 3g switched sockets & 4 x data
	3 Compartment Dado Trunking

DATA/TELEPHONE	
	Single RJ45 Data Outlet
	Twin RJ45 Data Outlet
	2 gang Outlet Plate for AV Termination
	Dedicated Telephone Outlet Point

DENOTATIONS

CL Cleaners Socket
HD Hand Dryer
WH Water Heater

MOUNTING HEIGHTS

Socket Outlets 450mm AFFL
Sockets, Spurs etc. Above Worktops
1050mm AFFL
Light Switches 1150mm AFFL
Hand Dryer Spur at 2200mm AFFL with
Outlet below at 1100mm AFFL
Any Specific Heights are Indicated
on the Drawing

Revisions



Freeman House
Ellen Street
Portslade
East Sussex. BN41 1DW
Tel: 01273 466700
Fax: 01273 466701
E-Mail: enquiries@dwelectrical.co.uk
Web: www.dwelectrical.co.uk

Client:

CARDENS

Project:

HOVE CLUB BUILDING
FORTH AVENUE
HOVE

Title:

POWER & DATA LAYOUT
FIRST FLOOR

Drawn: C. S.	Checked:
Scale: 1 : 50 @ A1	Date: OCT 2014
Drawing Number: D8551/E/02	Rev: